


GROUND FLOOR PLAN

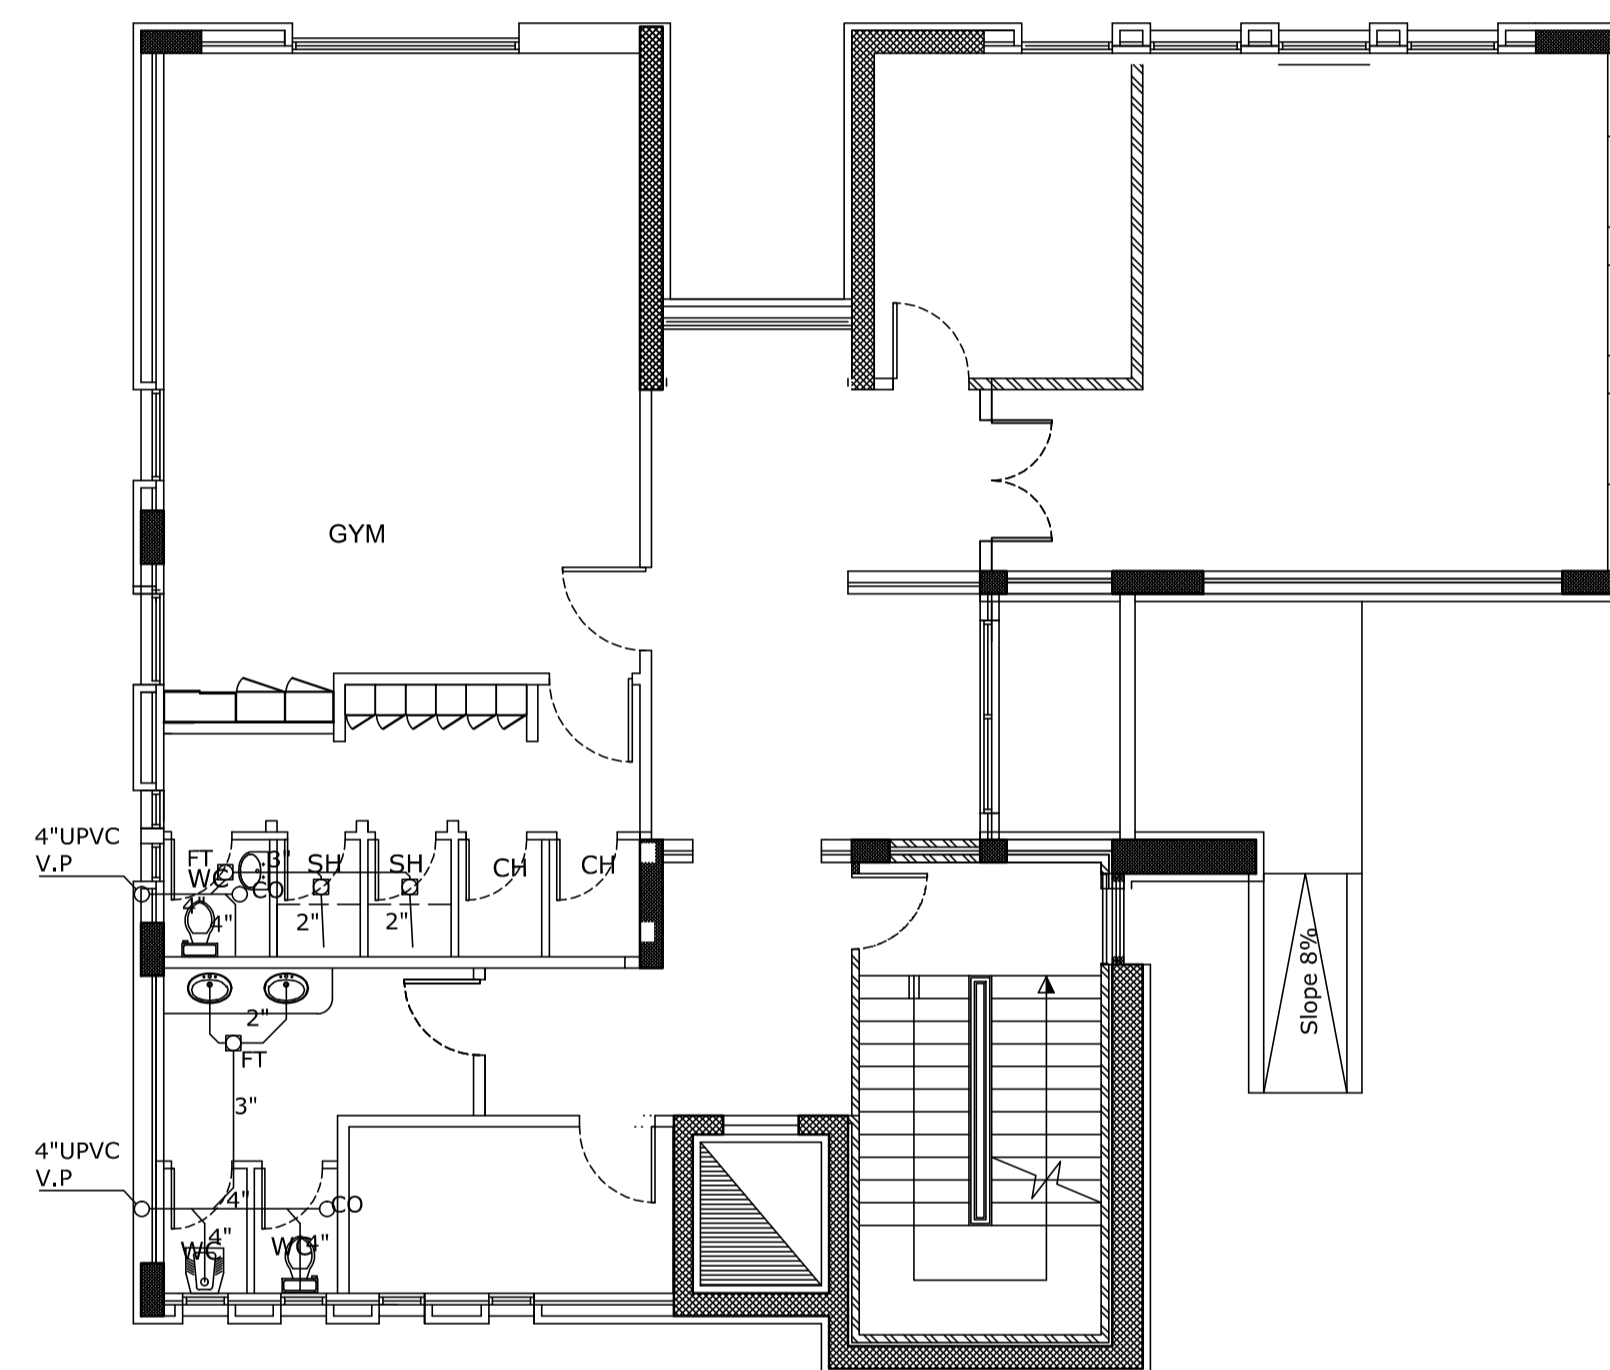

FIRST FLOOR PLAN

PROJECT NAME: نادي شباب سما السرحان



BUILDING STUDIES DEPARTMENT

DRAWING NAME:

DRAINAGE LAYOUT

EDITED BY:

ARCHITECT:

DRAFTED BY:

DINA JAFAR

RUHMA MOUSA

CIVIL.ENG.

ELECT. ENG.

MECH. ENG.

TASNIM ABU AWAD

REMAN QATAWNEH  
MUNA ZAYED

KHALID SALAMAT

SHEET NO.:

SCALE:

DATE:

M/01

1:100

2019

DIRECTOR OF GOVERNMENTAL BUILDING DIRECTORATE:

DIRECTOR OF BUILDING STUDIES DEPT.: NADIA ALAHMAD

HEAD OF BUILDING STUDIES SECTION: SUHAIR BURGAN